


FIRST FLOOR PLAN

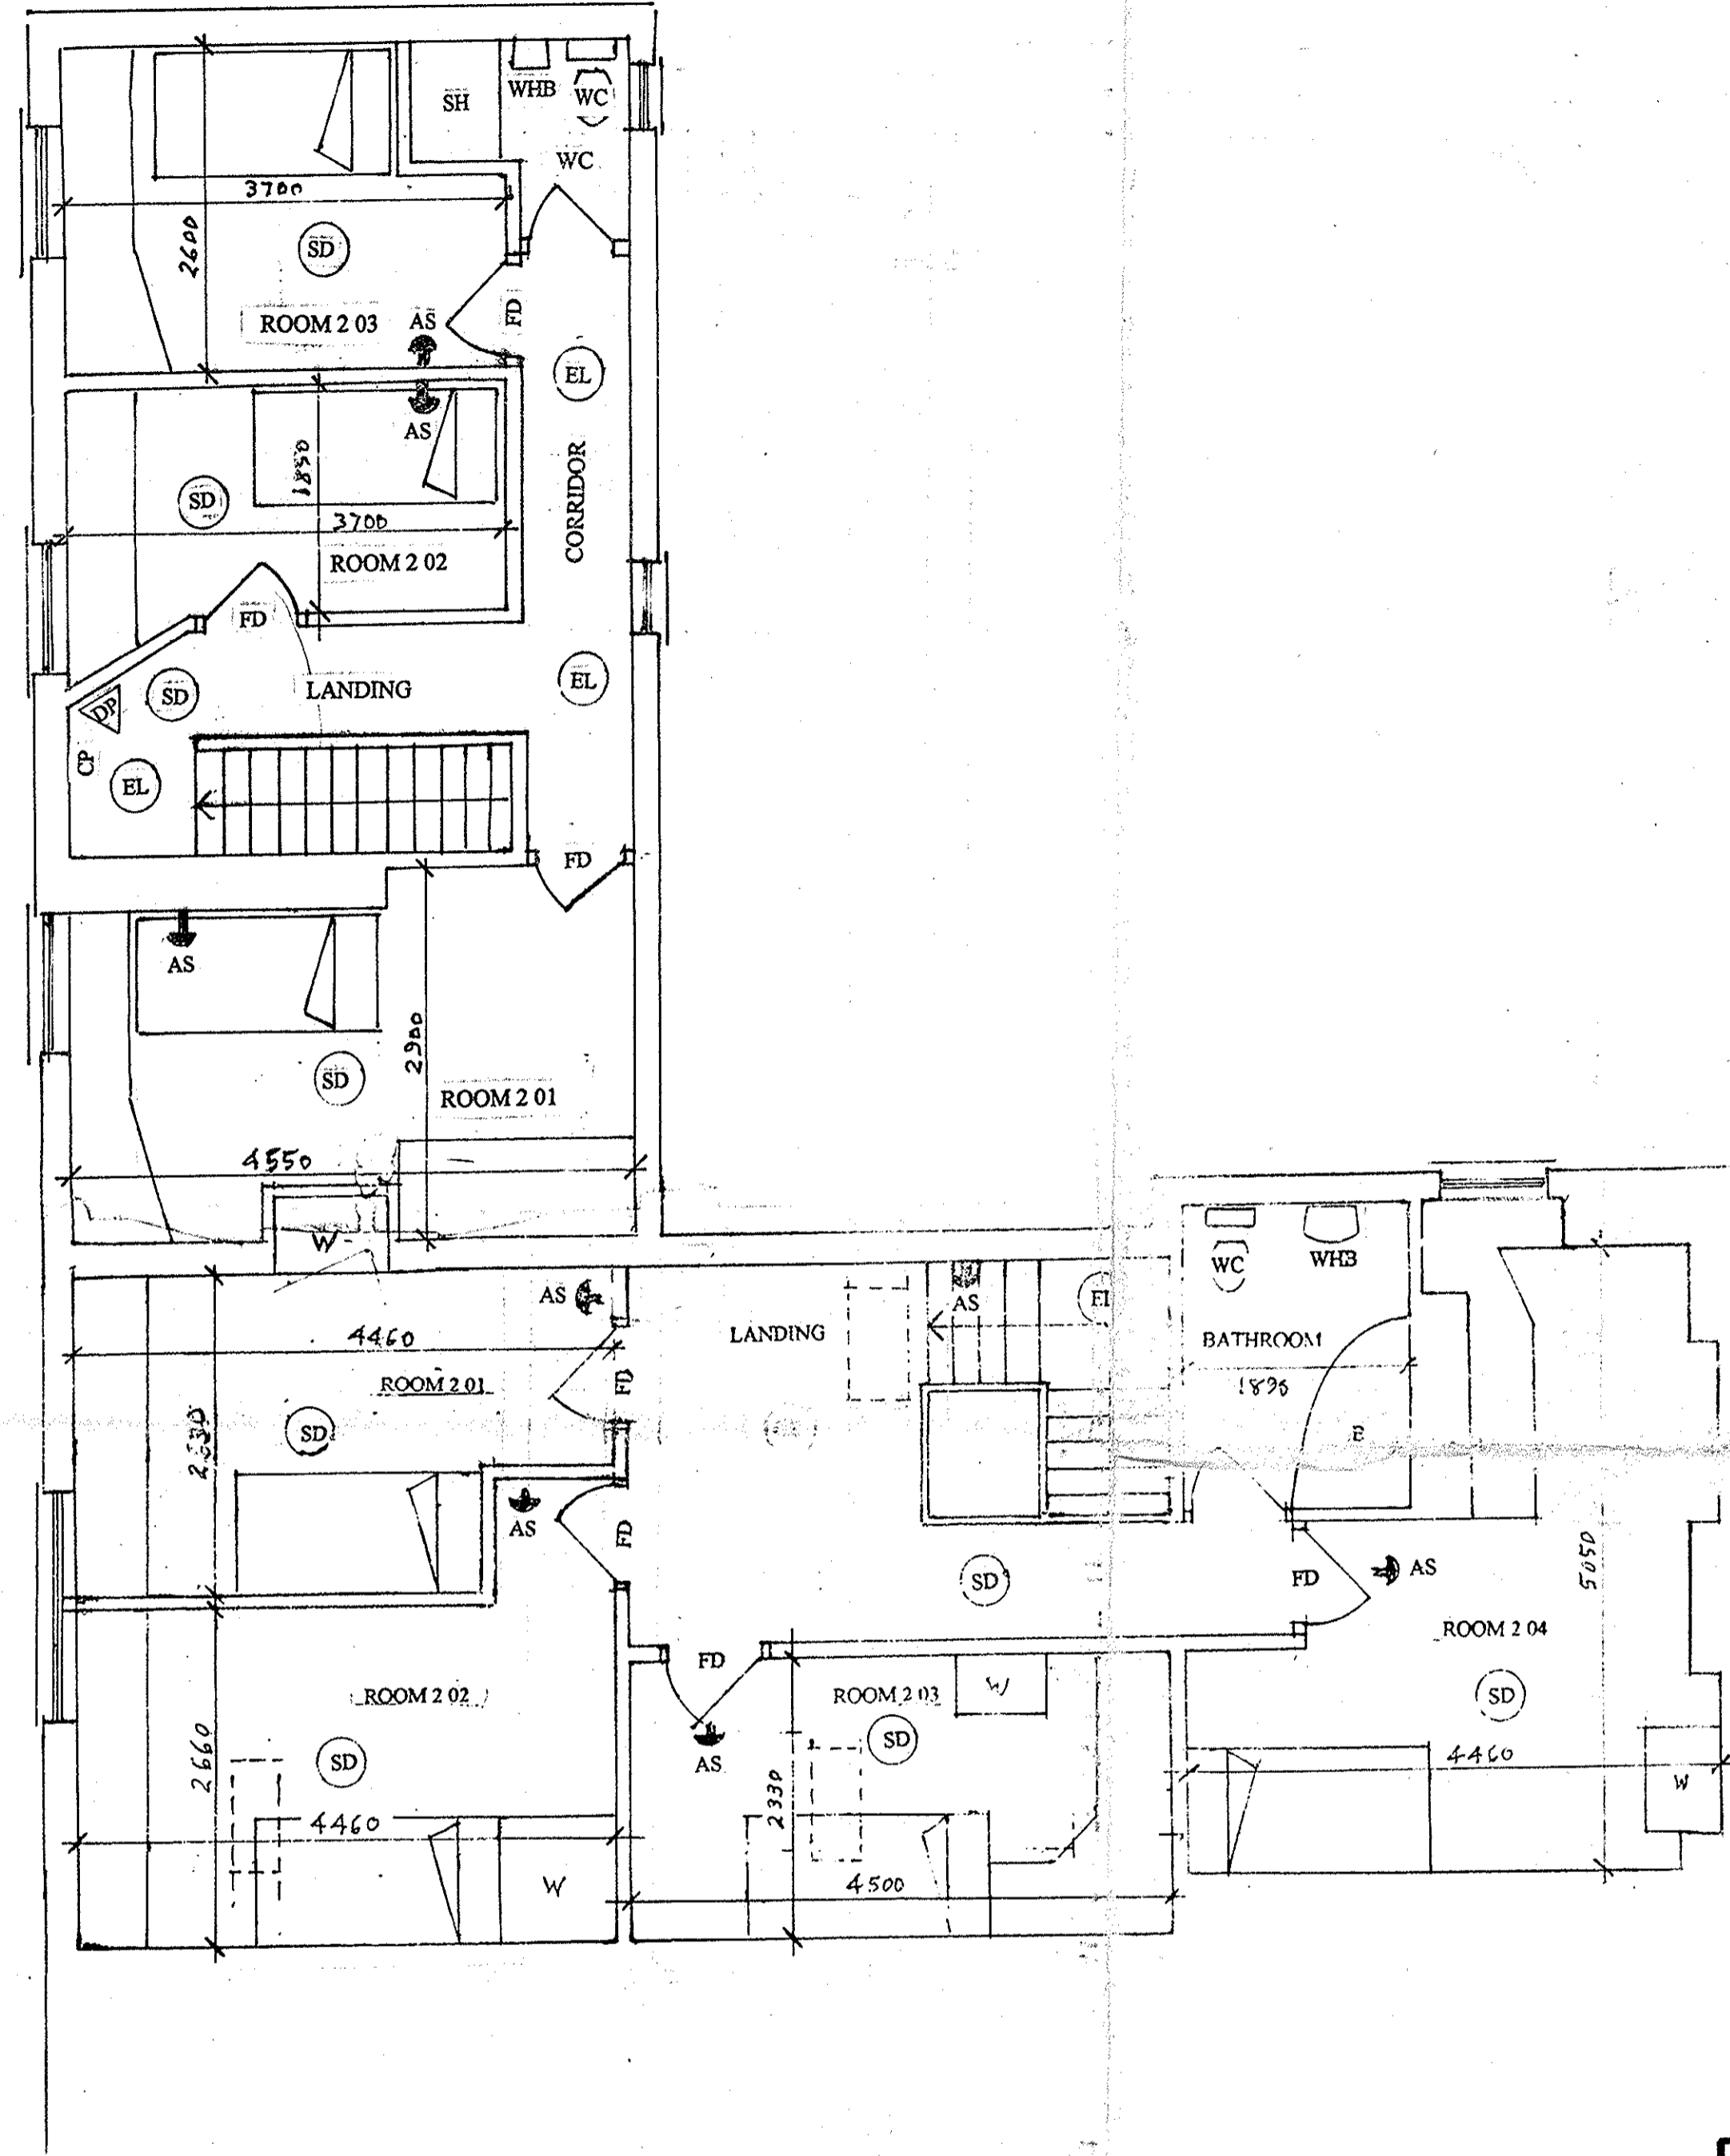

SECOND FLOOR PLAN

- Key of symbols**
- FD Fire door
  - EW Escape window
  - EL Emergency lighting
  - CP Manual call point
  - FAP Fire alarm control panel
  - SD Smoke detector linked to whole house system
  - HD Heat detector linked to whole house system
  - AS Alarm sounder linked to whole house system
  - SA Combined smoke detector/alarm, may be linked or stand-alone
  - HA Combined heat detector/alarm, may be linked or stand-alone
  - FB Fire blanket
  - WE Water extinguisher
  - FE Foam extinguisher
  - DP Dry powder extinguisher
  - SH Shower
  - B Bath
  - WC Toilet
  - WHB Wash-hand basin
  - C Cooler
  - S Sink
  - F Fridge

**MOLYNEUX SMITH  
CHARTERED  
ARCHITECTS**

54 GERTRUDE ROAD • WEST BRIDGFORD  
NOTTINGHAM NG2 5DB  
Tel: 0115 9822821 & 07973 181446

title:  
**PROPOSED ARRANGEMENT**  
**FIRST FLOOR PLAN**  
**SECOND FLOOR PLAN**

rev.	date	REVISIONS	scale	date
A	29:01:10	Various amendments to plans	1:50	29:10:08
drawing no.			drawn by	checked by
2036/AA(2) 07			ams	

Nos. 3A & 3B HARTLEY ROAD . NOTTINGHAM NG7 3AA